


REVISION -1 9-9-19 ON DATED - GOOD FOR CONSTRUCTION

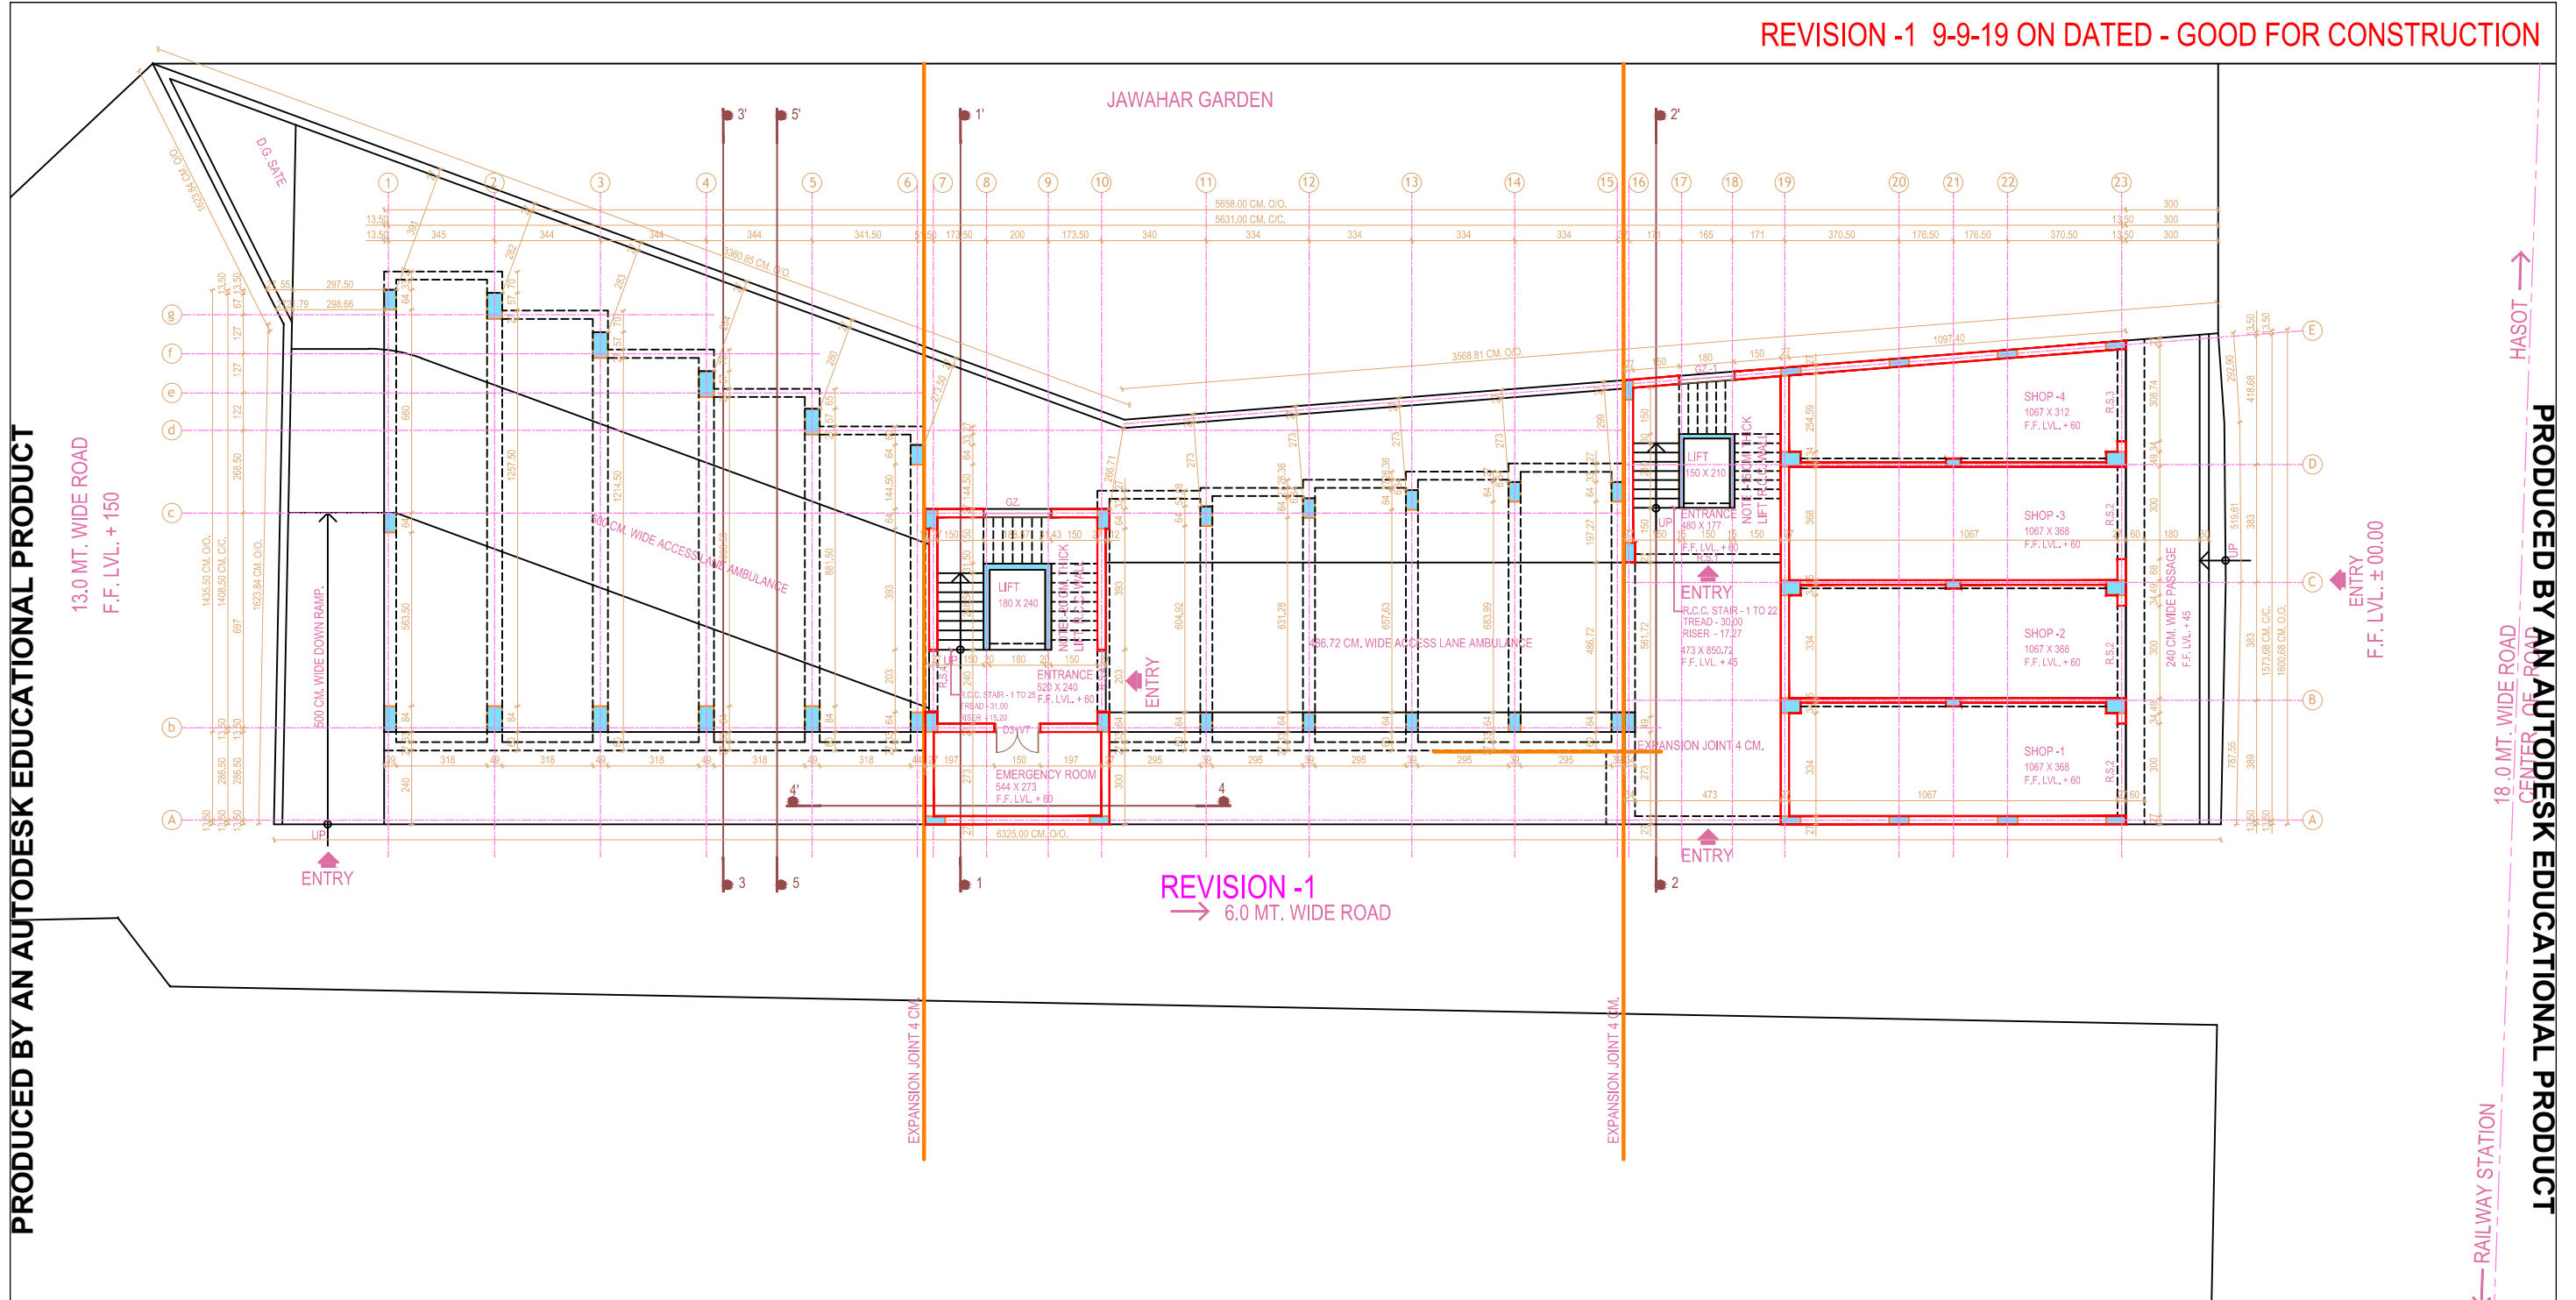

PRODUCED BY AN AUTODESK EDUCATIONAL PRODUCT

13.0 MT. WIDE ROAD  
F.F. LVL. + 150

PRODUCED BY AN AUTODESK EDUCATIONAL PRODUCT

HASOT

18.0 MT. WIDE ROAD

RAILWAY STATION

SCHEDULE OF OPENING'S -				SCHEDULE OF OPENING'S -				SCHEDULE OF OPENING'S -			
NO.	SIZE	SILL	LINTEL	NO.	SIZE	SILL	LINTEL	NO.	SIZE	SILL	LINTEL
R.S.	473 X 300	-	300	W2	213 X 202.50	7.50	210	V9	172 X 75	225	300
R.S.1	300 X 300	-	300	W3	209 X 202.50	7.50	210	V10	145 X 75	225	300
R.S.2	298 X 300	-	300	W4	120 X 202.50	7.50	210	V11	120 X 60	90	210
R.S.3	203 X 300	-	300	W5	60 X 202.50	7.50	210	V12	120 X 75	225	300
D	203 X 210	-	210	V	300 X 75	225	300	V13	100 X 75	225	300
D1	183 X 210	-	210	V1	298 X 75	225	300	V14	90 X 75	225	300
D2	154 X 210	-	210	V2	213 X 75	225	300	V15	60 X 120	90	210
D3	150 X 210	-	210	V3	209 X 75	225	300	V16	60 X 75	225	300
D4	120 X 210	-	210	V4	203 X 75	225	300	V17	45 X 120	90	210
D5	90 X 210	-	210	V5	183 X 75	225	300	V18	45 X 75	225	300
D6	75 X 210	-	210	V6	154 X 75	225	300				
W	300 X 202.50	7.50	210	V7	150 X 75	225	300	G2	220 X 1114	243.50	1357.50
W1	298 X 202.50	7.50	210	V8	172 X 60	150	210	G2-1	180 X 1114	243.50	1357.50

**NOTE:**

- \* ALL DIMENSIONS ARE IN CM.
- \* ALL DIMENSION ARE FINISHED DIMENSIONS.
- \* ALL DIMENSION ARE TO BE READ & NOT TO BE MEASURED.
- \* R.W.P. - RAIN WATER PIPE
- \* DO NOT CONSTRUCT ANY DUCT TILL THE COMPELLATION OF PLUMBING , SANITATION & AIR CONDITION WORK.
- \* IF ACTUAL QUANTITY EXCESS FROM TENDER QUANTITY , PLEASE BRING TO THE NOTICE OF ARCHITECT BEFORE EXECUTION . OTHERWISE NO CLAIM WILL BE ENTERTAINED.

JOB TITLE  
PROPOSED MUNICIPAL HOSPITAL ANKLESWAR, BHARUCH.

DRG. TITLE  
GROUND FLOOR PLAN



JOB NO.:		DRG. NO.:	
CI / F / B		WKD NO.	
SCALE		REVISION SUFFIX	
N.T.S.	DATE	REALT	CHECKED
	9/9/19	SHAHL	

ARCHITECT & CONSULTANT  
**SHAILESH MODI**  
PANCH BATTI, BHARUCH + 392 001  
PH. NO. O. 243607 R. 241107